



**DEPARTMENT OF FINANCE**

**PROCUREMENT SERVICES**

95 Rochford Street, 2<sup>nd</sup> Floor South, Shaw Building, Room 27

Charlottetown, PEI, C1A 7N8

Telephone: (902) 368-4040 or Facsimile (902) 368-5171

**ADDENDUM # 1**

**For RFQ # 5634**

**TO: All Bidders**

**FROM: Procurement Services**


**DATE: January 7, 2021**

**SUBJECT: Additional information – Floor Plans**

---

Please see the following page showing the floor plan for École Pierre-Chiasson.

# Erde Pierre Chaison DEBLOIS

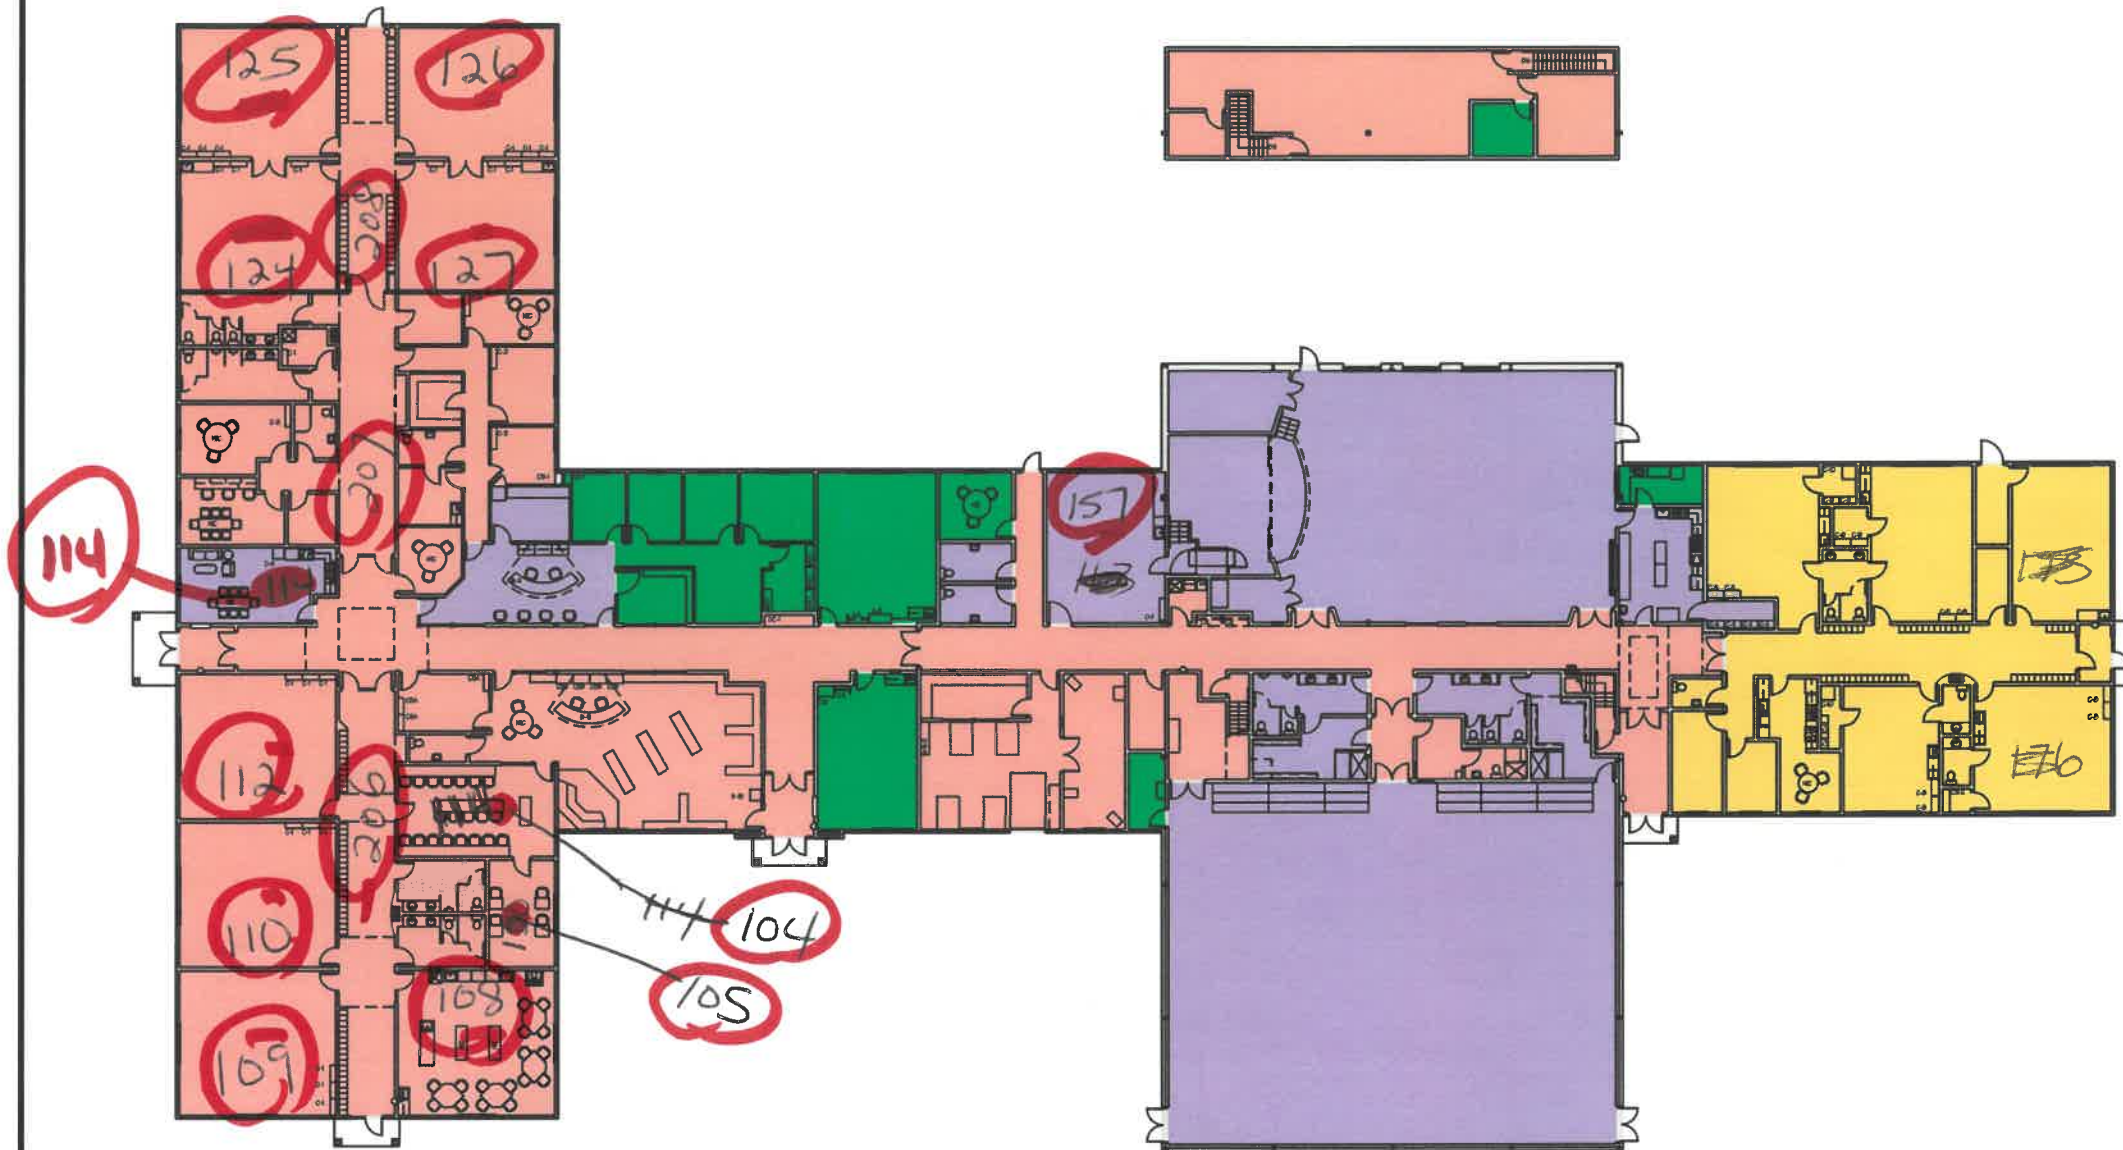

S:\Bldg CadStd\1\8\workspace\system\lib\ables\pen\GENERAL TABLES\GenPlotCFG.tbl  
 V:\Temp-Plots\CAD Plots\Wray M\Richardson T\French School Plots\Radon Plots.dgn  
 2/19/2008 3:26:05 PM  
 LEDGER M AEC

<p>           Prince Edward Island            CANADA            Tel 902 368 5100            Fax 902 368 5395  <a href="http://www.gov.pe.ca/">http://www.gov.pe.ca/</a> </p>	<b>Transportation and Public Works</b>  PO Box 2000 Charlottetown Prince Edward Island Canada C1A 7N8
	<p>           A = Detail #            BB = Sheet # ( Where Detail Required )            CC = Sheet # ( Where Detailed )         </p>
<b>Project Title :</b> <i>West Prince French School</i>	
<b>Drawing Title :</b> <i>Main Floor Plan - Area Usage</i>	
<b>Scale :</b> 1 : 400	<b>Design By :</b>
<b>Drawn By :</b>	<b>Date :</b>
<b>Project No.:</b> 0000 - 0000	<b>Drawing # :</b> WP1 of 1